

PROJECT:  
**ELMORE COUNTY PS2**PROJECT ADDRESS:  
**2180 AMERICAN LEGION  
BOULEVARD,  
MOUNTAIN HOME, ID 83647**OWNER:  
**SHELLEY ESSL, COUNTY CLERK  
ELMORE COUNTY  
150 SOUTH 4TH EAST, SUITE 3  
MOUNTAIN HOME, IDAHO 83647**

## NOTES

1. CALL 811 BEFORE DIGGING.
2. CONTRACTOR SHALL FIELD VERIFY ALL UTILITY CROSSING PIPE INVERT ELEVATIONS PRIOR TO CONSTRUCTION.
3. UTILITY LOCATIONS SHOWN ARE APPROXIMATE. CONTRACTOR SHALL VERIFY THE LOCATION AND DEPTH OF ALL EXISTING UTILITIES PRIOR TO EXCAVATION.
4. IMMEDIATELY NOTIFY THE ENGINEER OF ANY CONFLICTS BETWEEN EXISTING AND PROPOSED UTILITIES BEFORE PROCEEDING WITH CONSTRUCTION.
5. PROTECT EXISTING UTILITIES AND FACILITIES FROM DAMAGE DURING CONSTRUCTION. REPAIR ANY DAMAGE CAUSED BY CONSTRUCTION ACTIVITIES AT NO ADDITIONAL COST TO THE OWNER.
6. MAINTAIN MINIMUM REQUIRED HORIZONTAL AND VERTICAL CLEARANCES BETWEEN UTILITIES IN ACCORDANCE WITH APPLICABLE CODES AND UTILITY OWNER REQUIREMENTS.
7. FIELD ADJUSTMENTS TO UTILITY ALIGNMENTS MAY BE REQUIRED TO AVOID CONFLICTS WITH EXISTING UTILITIES AND SHALL BE COORDINATED WITH THE ENGINEER.

## KEY NOTES

1. INSTALL FIRE HYDRANT ASSEMBLY. SEE DETAIL #1 ON SHEET C3-02. 3 EACH.
2. INSTALL 6" SANITARY CLEANOUT. SEE DETAIL #2 ON SHEET C3-02. 1 EACH.
3. CONNECT TO EXISTING SANITARY SEWER. INSTALL STANDARD MANHOLE. SEE DETAIL #7 ON SHEET C3-02. 1 EACH.
4. INSTALL 6" SANITARY LATERAL AND 4"x8" TEE. SEE DETAIL #6 ON SHEET C3-02. 2 EACH.
5. INSTALL WATER LINE CONNECTING TO BUILDING. 1 EACH.
6. INSTALL 6" WATER LINE. 259 LF TOTAL.
7. CONNECT 6" WATER LINE TO EXISTING WATER LINE. FIELD TO VERIFY EXIST WATER LINE SIZE. INSTALL TEE. 3 EACH.
8. INSTALL INLET. SEE DETAIL #1 & 2 ON SHEET C3-03. 5 EACH.
9. INSTALL VAULT FOR SAND AND GREASE TRAP. SEE DETAIL #5 ON SHEET C3-03. 3 EACH.
10. INSTALL SEEPAGE BED. SEE DETAIL #6 ON SHEET C3-03.
11. INSTALL 6" SANITARY SEWER. 365 LF.
12. RECONNECT EXISTING SANITARY LATERAL TO PROPOSED BUILDING. 1 EACH.
13. CONNECT PROPOSED WATER LINE TO EXISTING WATER AND RELOCATE GATE VALVE. 1 EACH.
14. CONNECT PROPOSED GAS MAIN TO EXISTING GAS MAIN. FIELD TO VERIFY THE SIZE OF EXISTING GAS PIPE. 16 LF.
15. INSTALL 2" WATER LINE TO 6"x2" TEE. 185 LF TOTAL.
16. INSTALL 2" GATE VALVE. 2 EACH.
17. INSTALL 4" STORM SEWER. IE 3144.83. SEE SHEET P-110 FOR PIPE CONNECTION.
18. INSTALL 3" STORM SEWER. FIELD TO VERIFY FOR INVERT ELEVATION AT THE CONNECT POINT. SEE SHEET P-110 FOR PIPE CONNECTION.
19. INSTALL STANDARD MANHOLE. SEE DETAIL #7 ON SHEET C3-02. 3 EACH.
20. PROTECT EXISTING WATER METER. REUSE METER FOR WATER SERVICE TO PS2 BUILDING.
21. INSTALL WATER METER FOR WATER SERVICE TO RESCUE BUILDING.

APPROVAL STAMPS



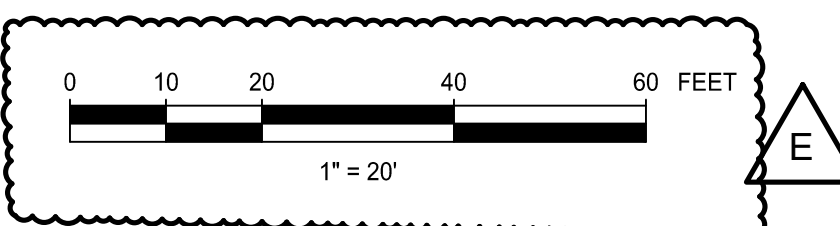
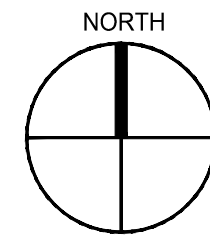
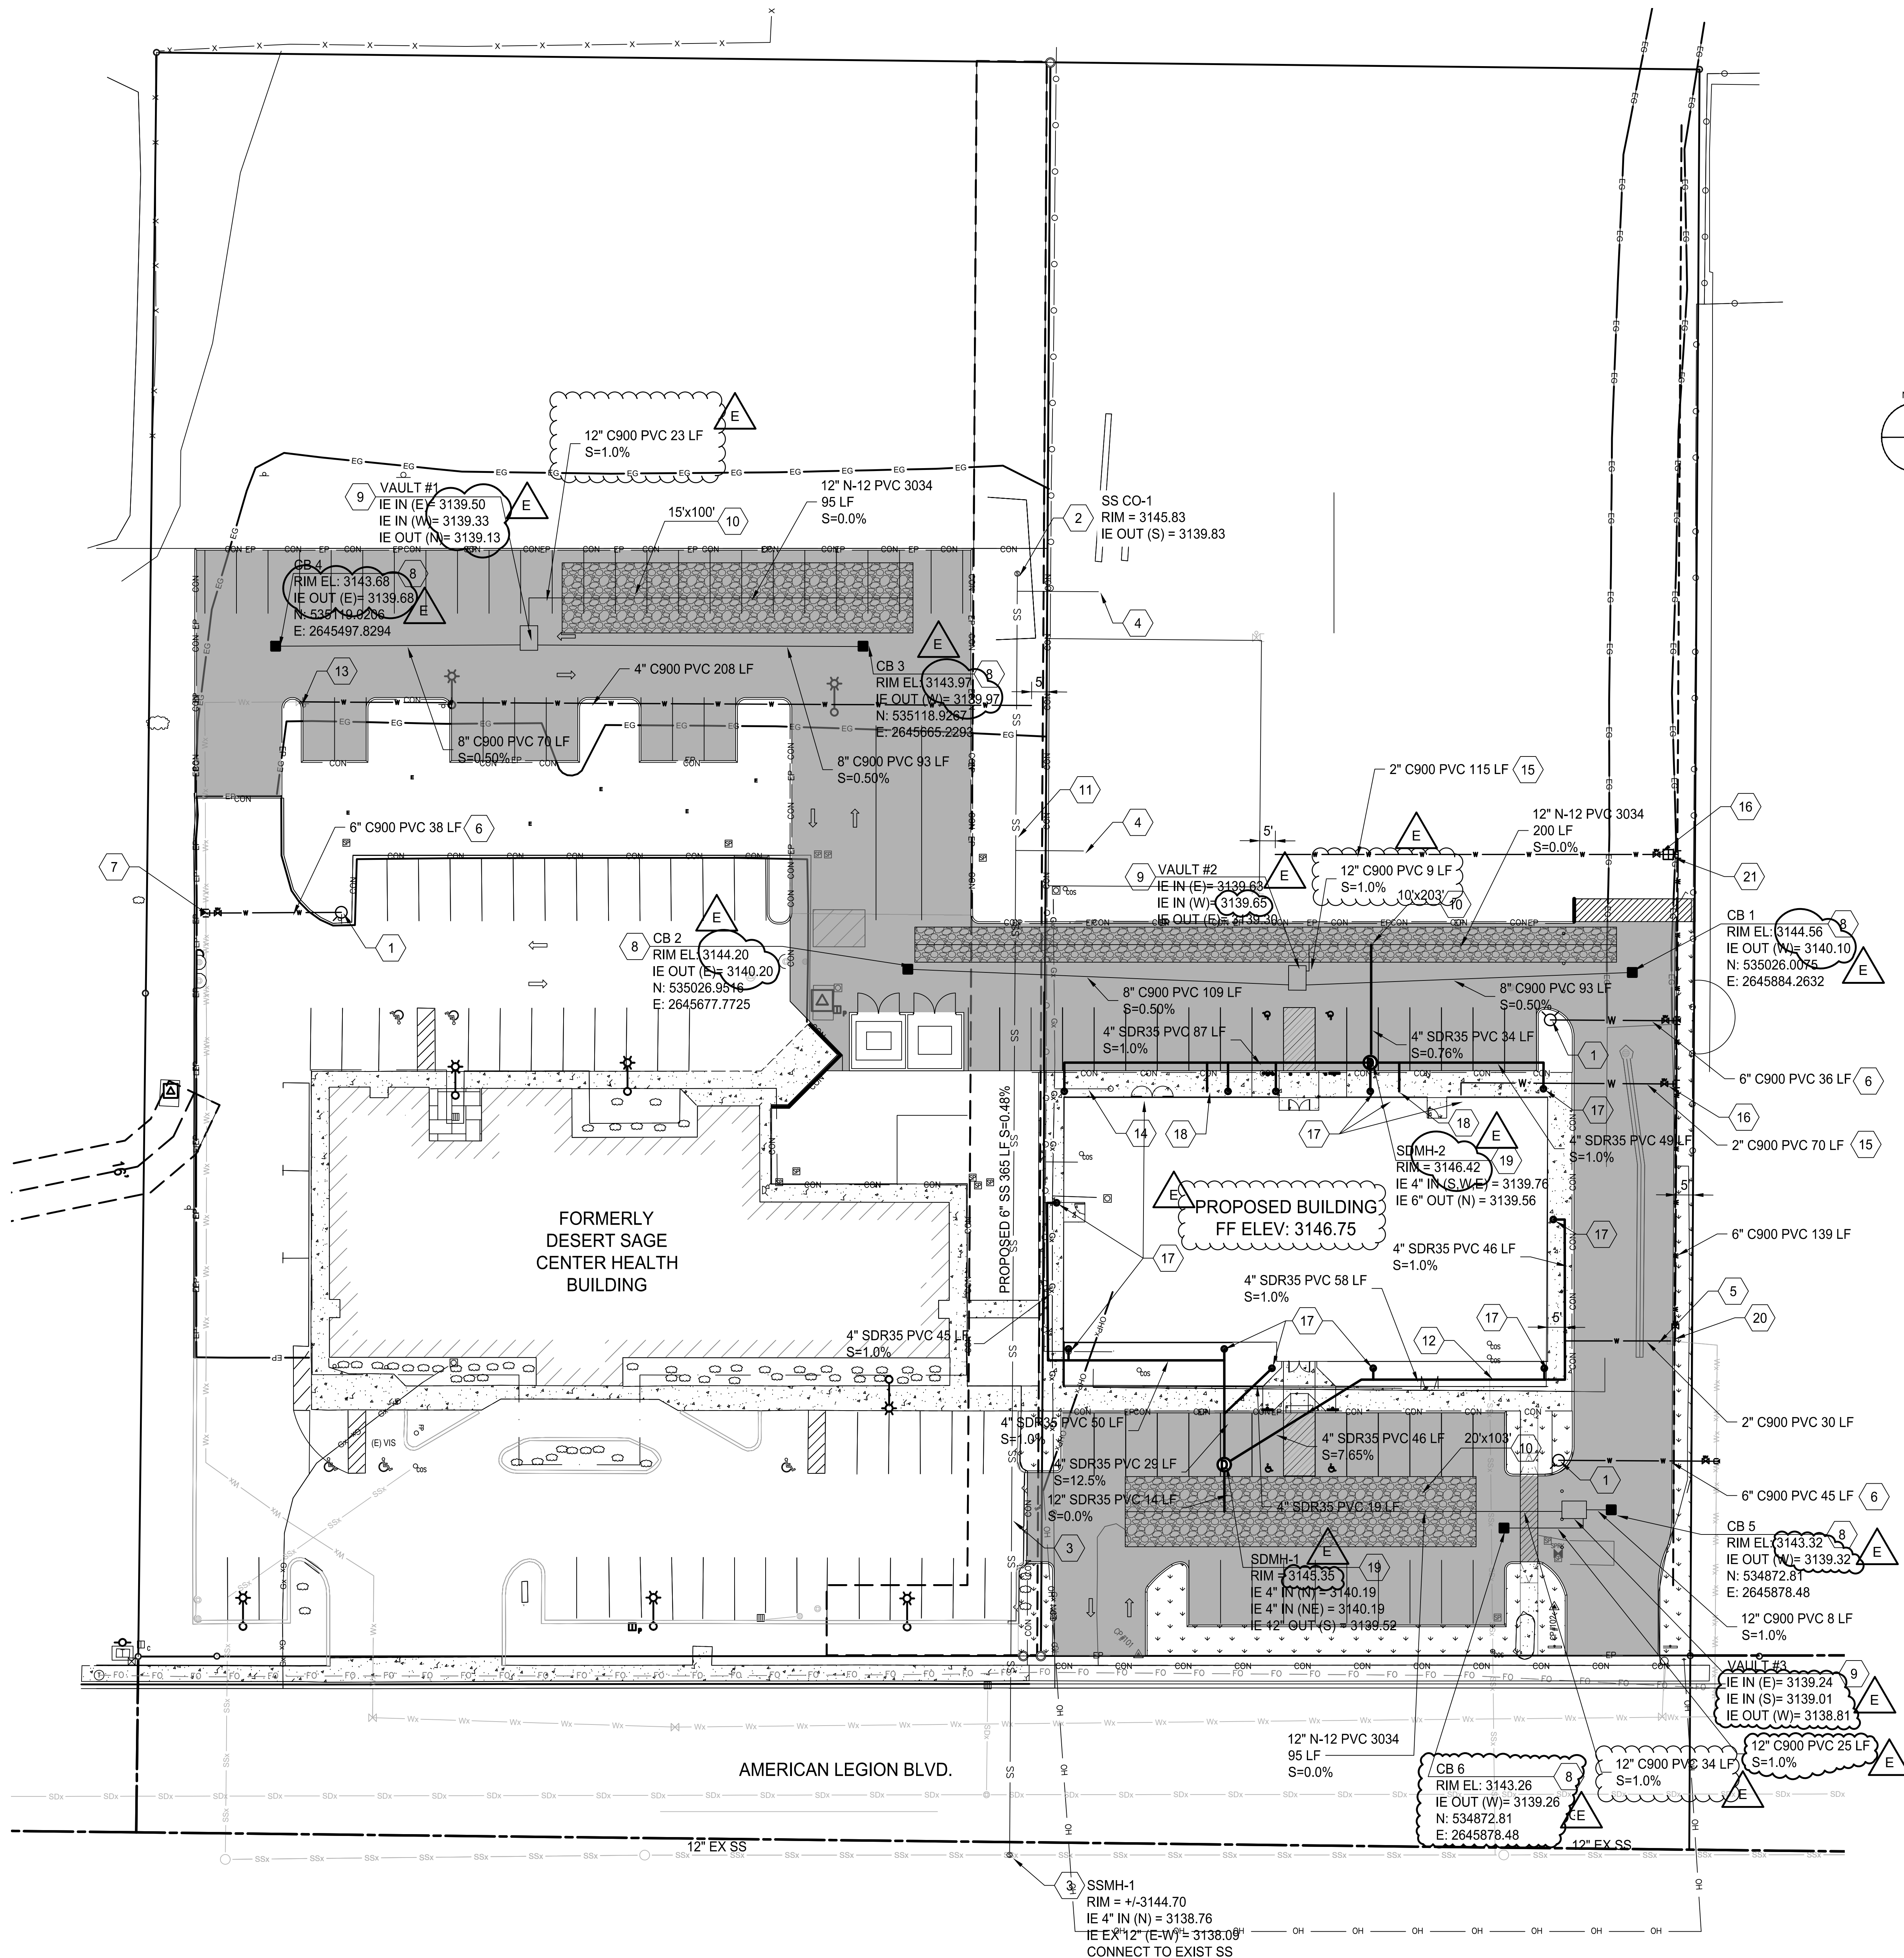
## REVISIONS

| MARK | DATE       | DESCRIPTION               |
|------|------------|---------------------------|
| E    | 08/27/2026 | ADDENDUM #4               |
| D    | 11/05/2025 | PREAPPLICATION COMMENTS   |
| C    | 09/05/2025 | 50% CD / OWNER REVIEW SET |
| B    | 08/01/2025 | 100% DESIGN DEVELOPMENT   |
| A    | 07/03/2025 | 50% DESIGN DEVELOPMENT    |

## ISSUE INFORMATION

PROJECT NO.: **US0043131.4394**  
WSP PRINCIPAL IN CHARGE: **KRISJAN HINER**  
WSP PROJECT MANAGER: **RICHARD SERVOS**  
OWNER APPROVAL:SHEET TITLE  
**UTILITY PLAN**

SHEET NO.

**C3-01**COPYRIGHT GGLO. ALL RIGHTS RESERVED.  
ORIGINAL SHEET SIZE: 11.0'x17.0'

PERMIT SET